


PLOTTED: Wednesday, September 2, 2020 1:01:30 PM

X-REFS: C:\USERS\CALLIENDESK\TOP\COURTWAY LIGHTING  
FILE PATH:

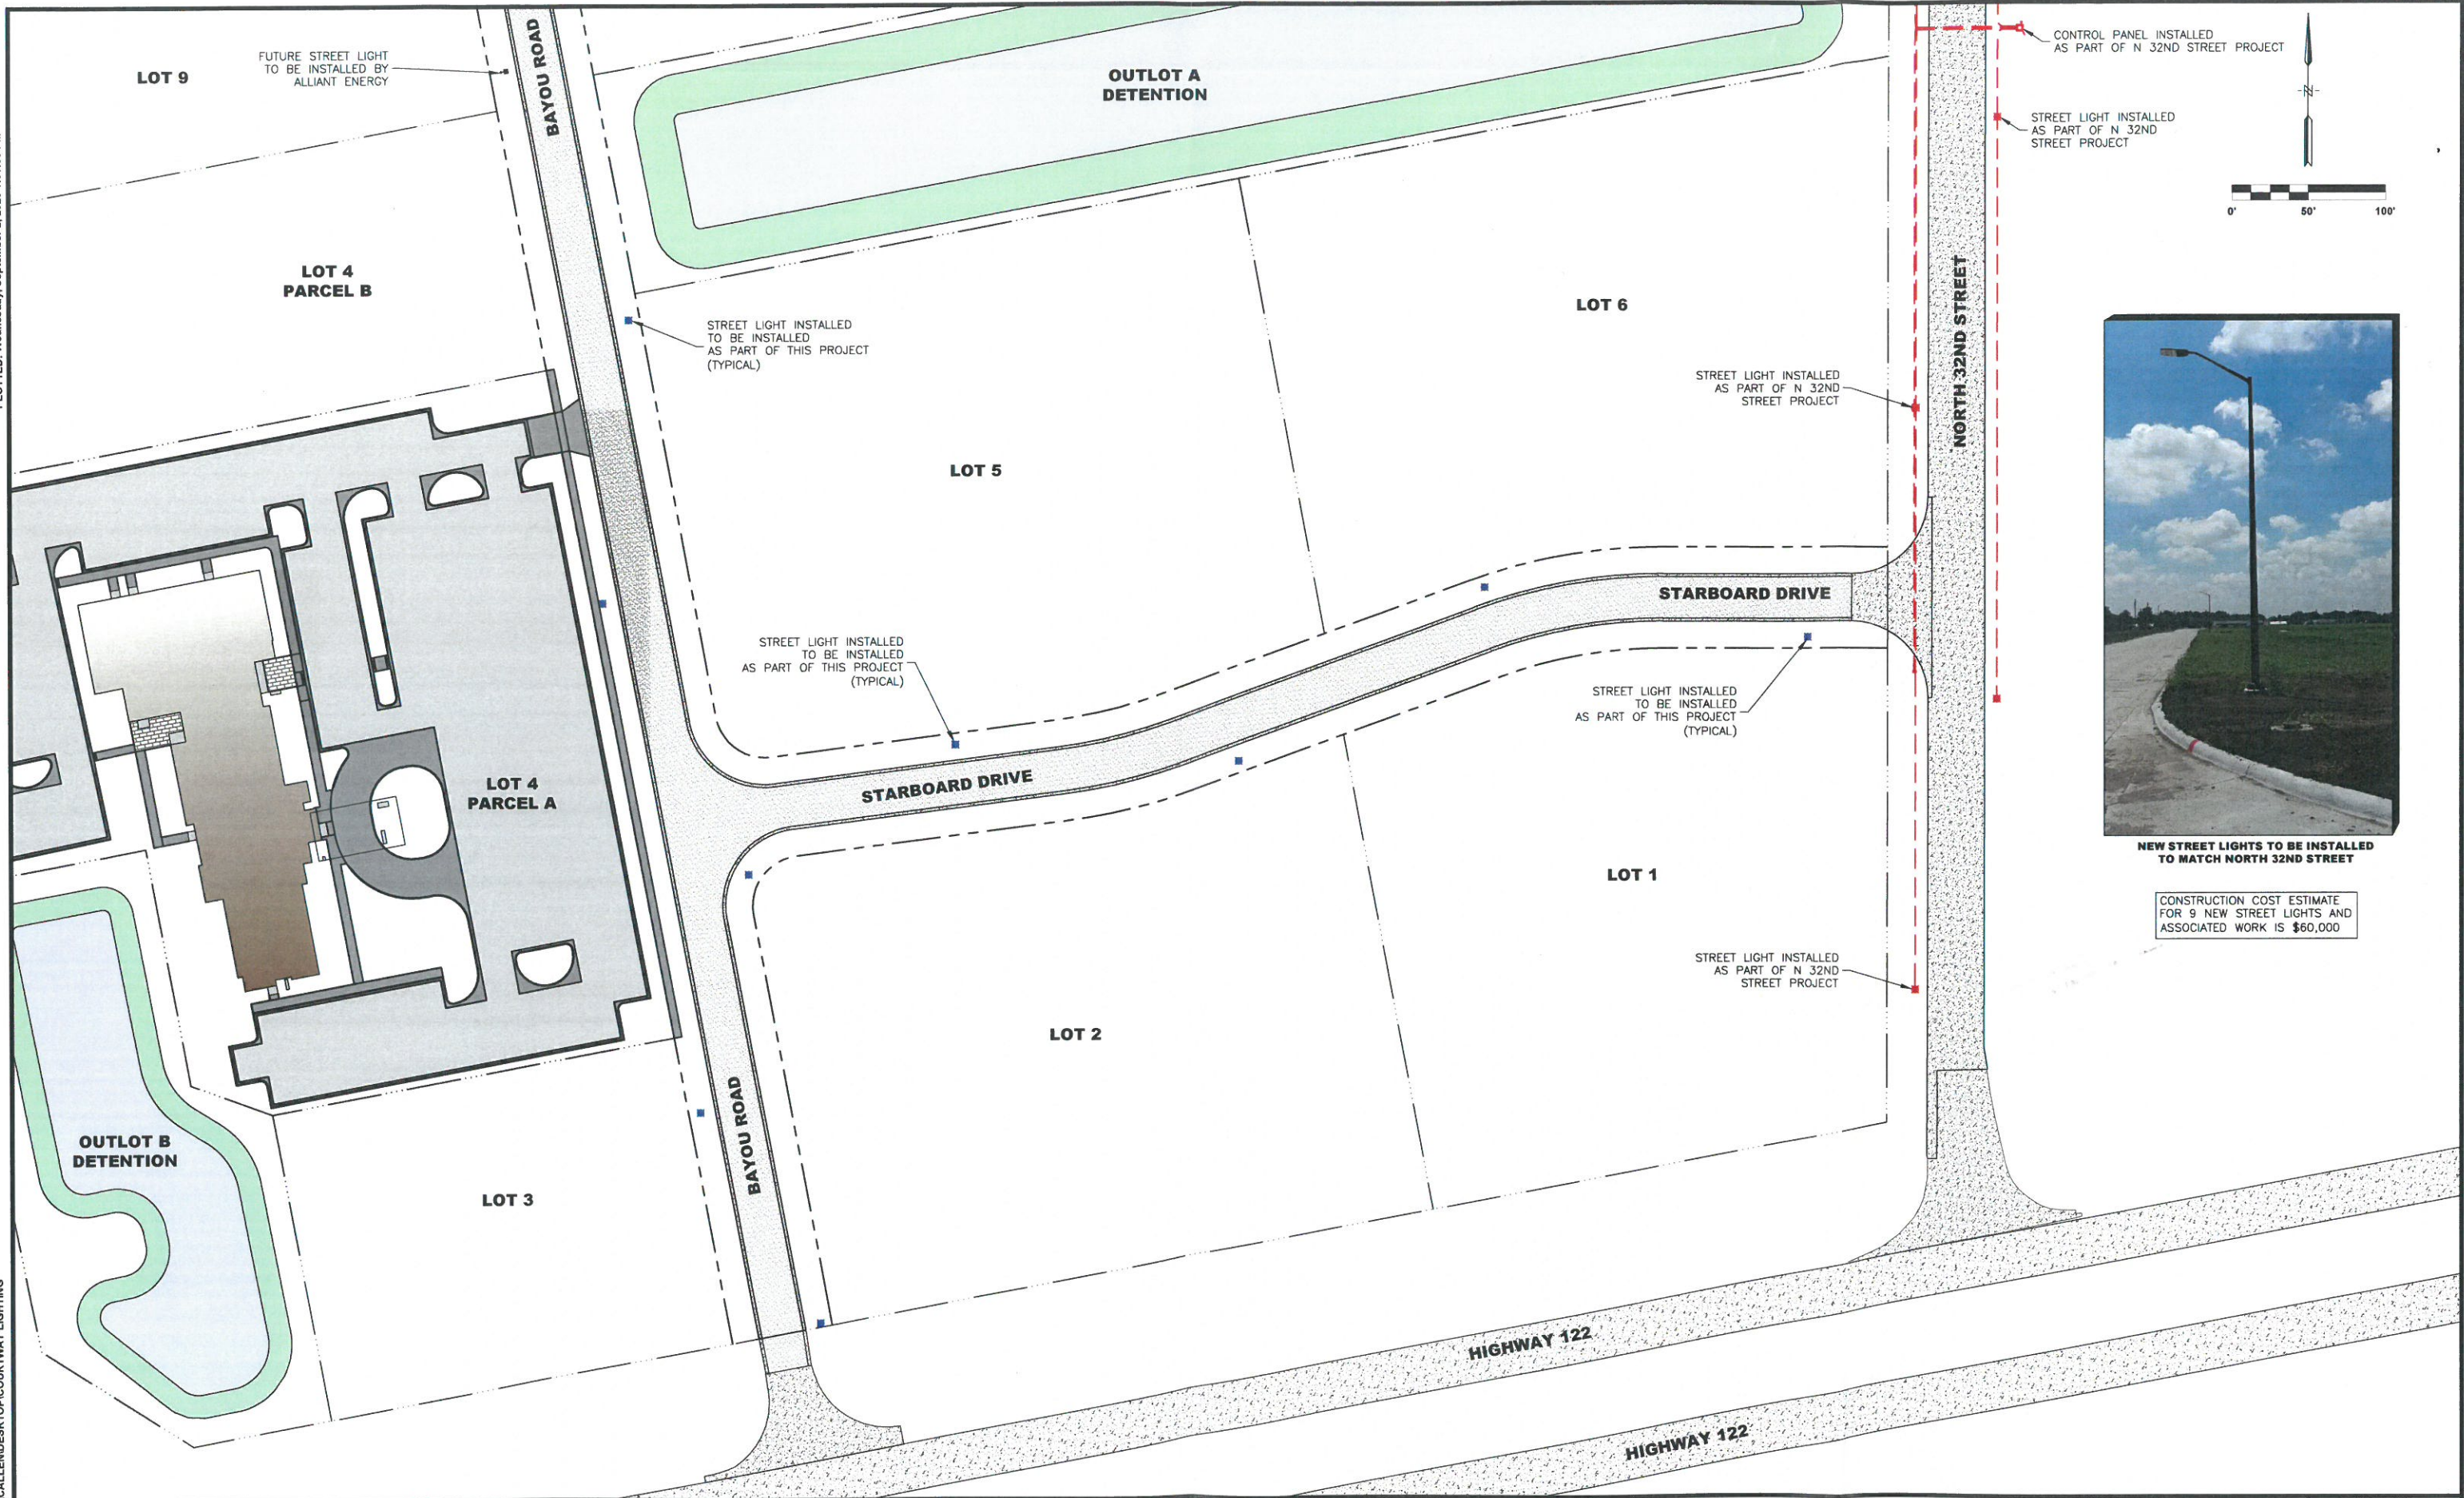

NEW STREET LIGHTS TO BE INSTALLED TO MATCH NORTH 32ND STREET

CONSTRUCTION COST ESTIMATE FOR 9 NEW STREET LIGHTS AND ASSOCIATED WORK IS \$60,000

DATE	REVISIONS	SCALE	AS NOTED
		DRAWN	CALLIEN
		CHECKED	XXX
		APPROVED	XXX
		DATE	9/2/2020
		ISSUED FOR	PRELIMINARY

VERIFY SCALE  
BAR IS ONE INCH ON ORIGINAL DRAWING.  
0 1"  
IF NOT ONE INCH ON THIS SHEET, ADJUST SCALES ACCORDINGLY.

**V&K**  
**VEENSTRA & KIMM, INC.**

**COURTWAY PARK STREET LIGHTING**  
CLEAR LAKE, IOWA

2800 Fourth Street SW • Suite 9 • Mason City, Iowa 50401-1596  
641-421-8008 • 641-380-0313(FAX) • 877-241-8008(WATS)

**OVERALL LIGHTING PLAN**

DWG. NO.	1 OF 1
PROJECT	###