



KC ENGINEERING, P.C.
4300 So. Lakeport, Suite 205
Sioux City, Iowa 51106
(712) 252-2100

PROJECT TITLE:
**T.JN ENTERPRISES
SIOUX FALLS,
SOUTH DAKOTA**


SHEET TITLE:
**PROPOSED
SITE PLAN**

REVISIONS		
13		
12		
11		
10		
9		
8		
7		
6		
5		
4		
3		
2		
1		
MARK	DATE	DESCRIPTION


PROJECT STATUS:

PROJECT DATE: 09-22-11
PROJECT NO: 60147
DRAWN BY: MEJ
PROJECT MANAGER: C.E.


SHEET NO:
1

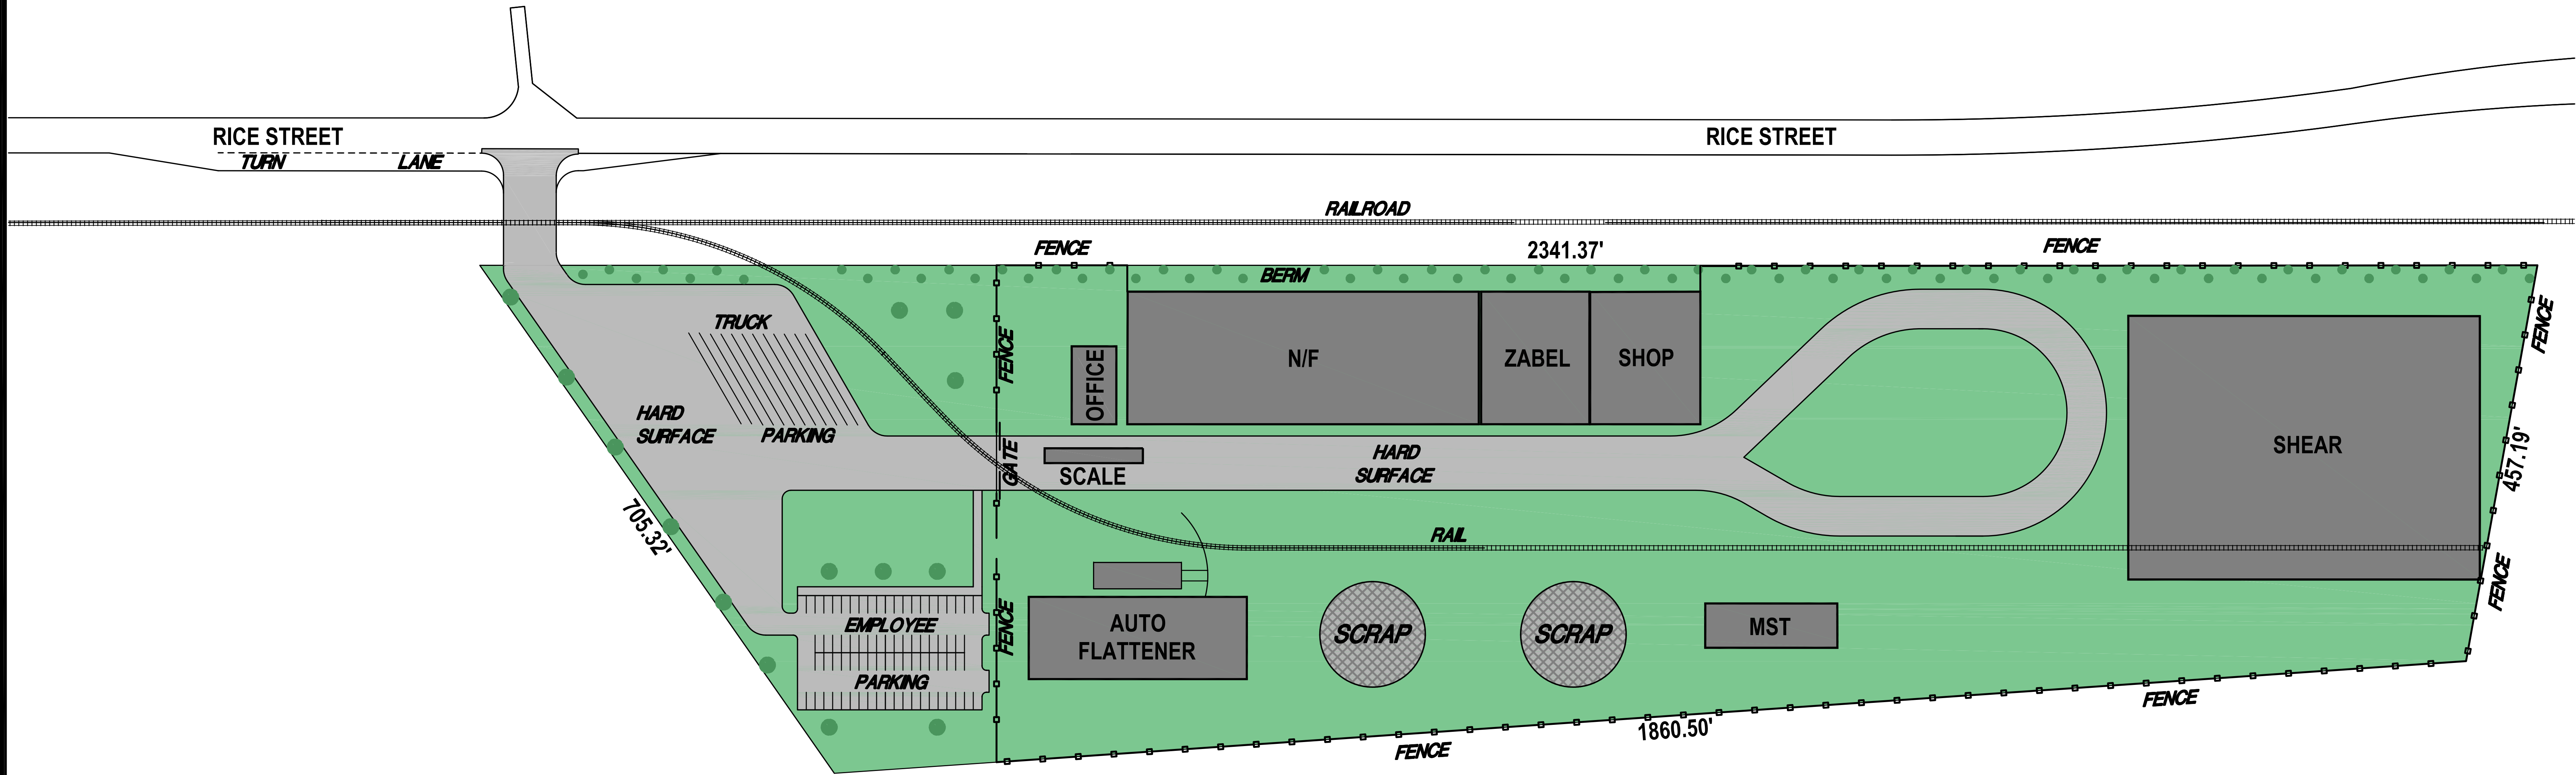

0 50 100 300
SCALE:
1"=80'-0"

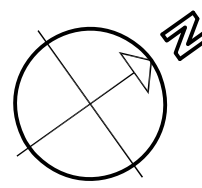

PROPOSED SITE PLAN
SCALE: 1"=80'-0"

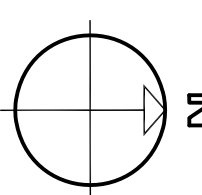

PLAN NORTH